



**BASEMENT ELECTRICAL PLAN**

SCALE: 3/16" = 1'-0"

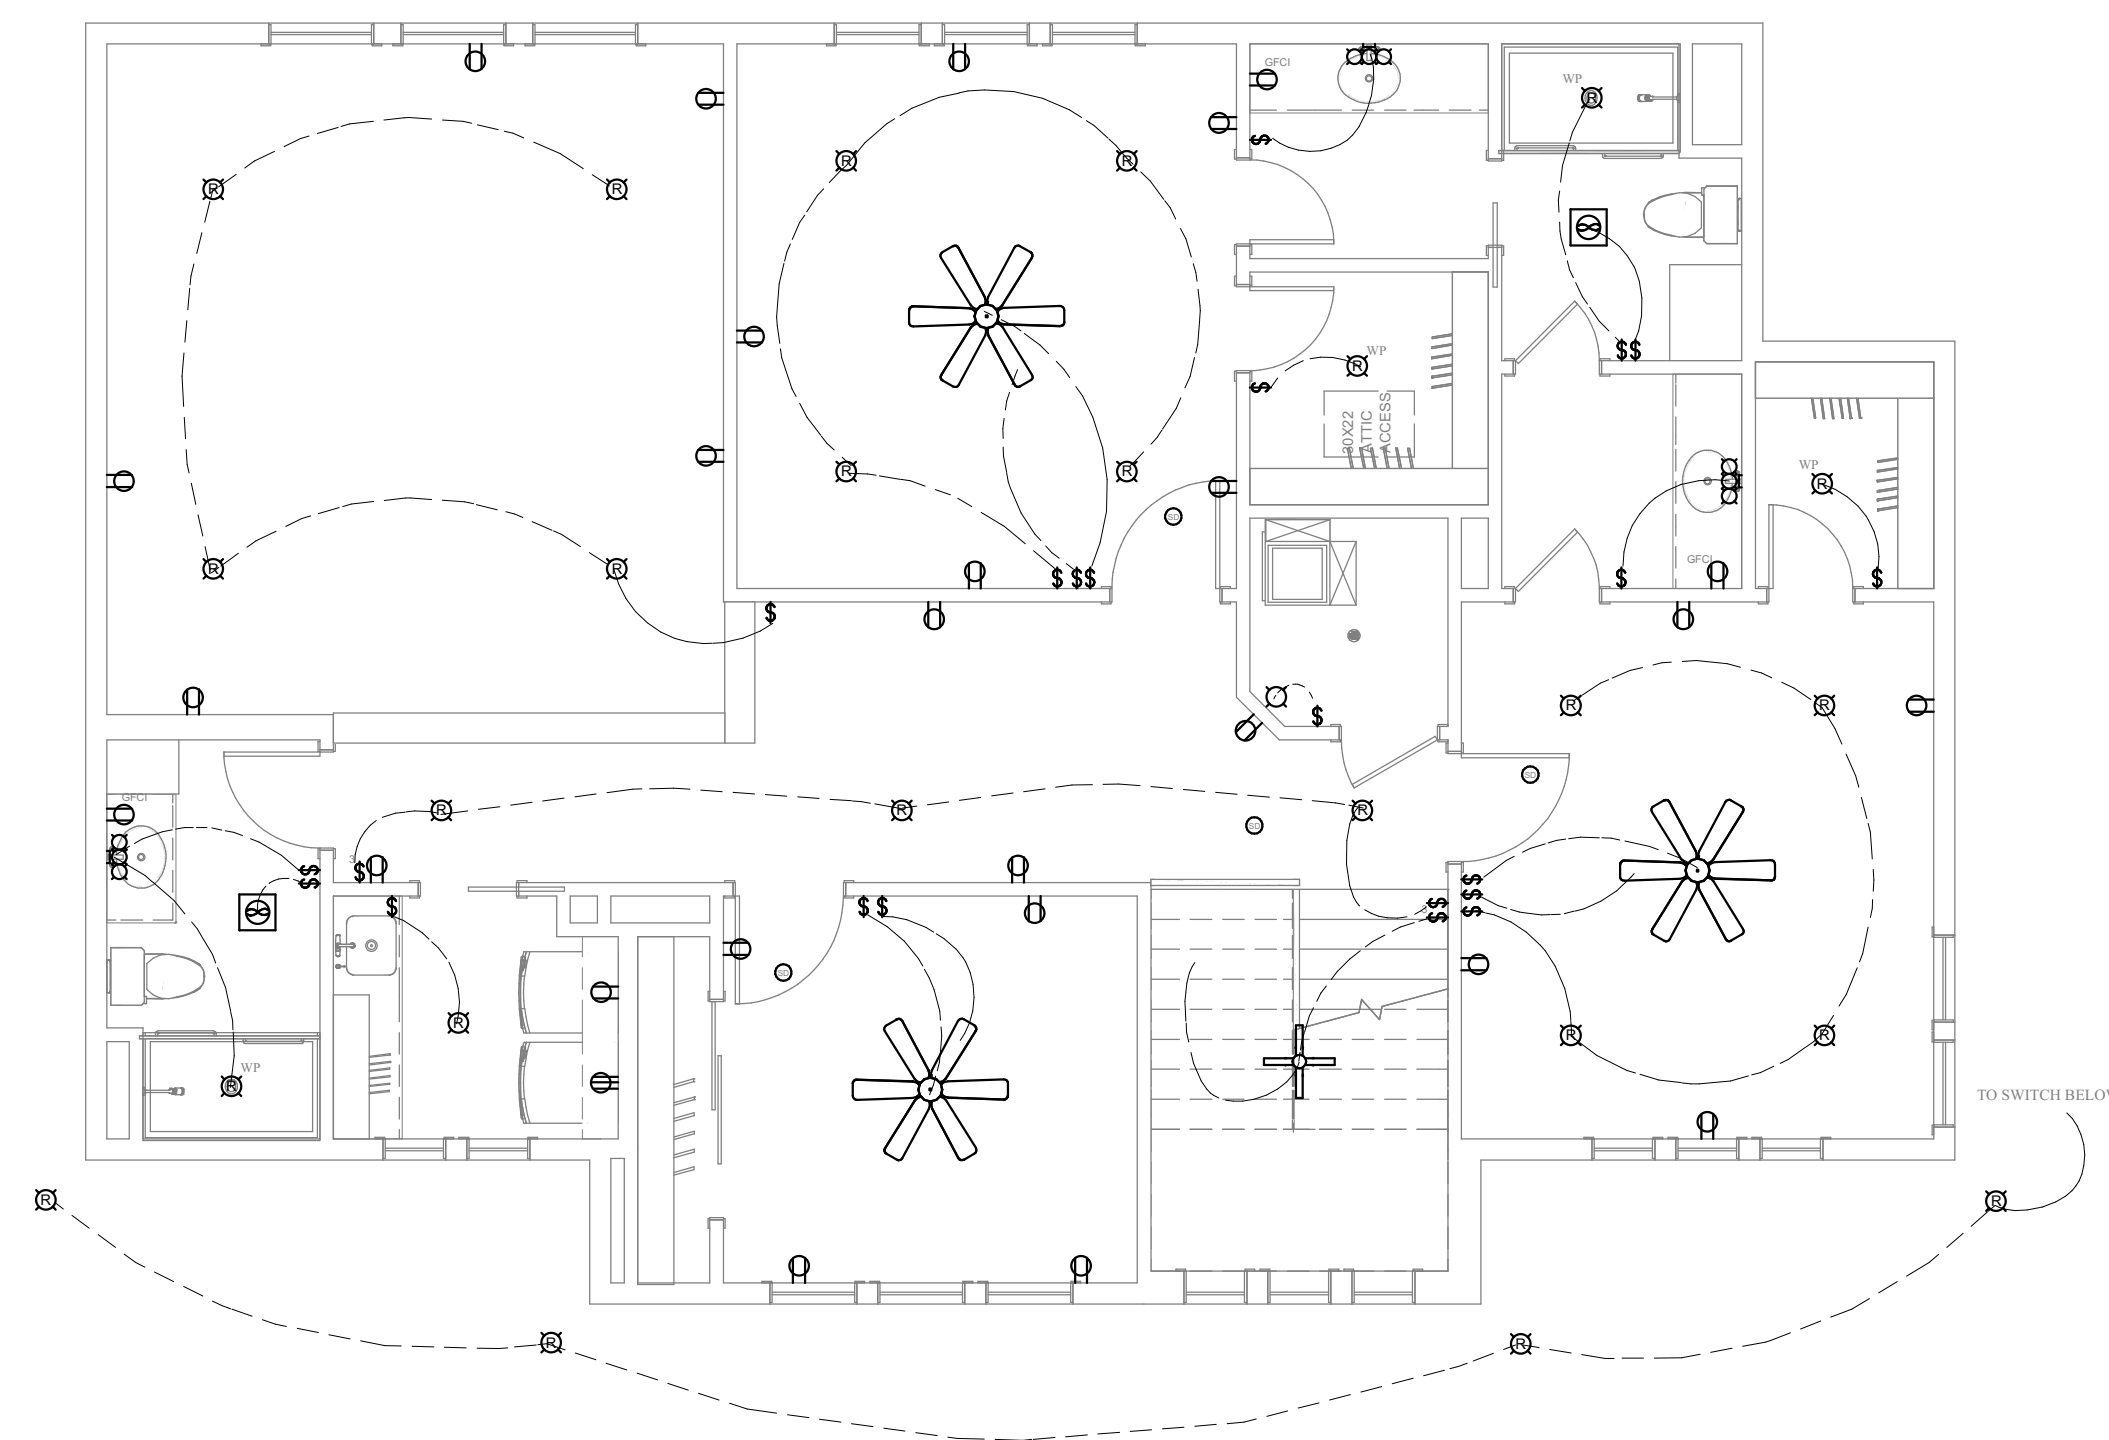


**UPPER LEVEL ELECTRICAL PLAN**

SCALE: 3/16" = 1'-0"

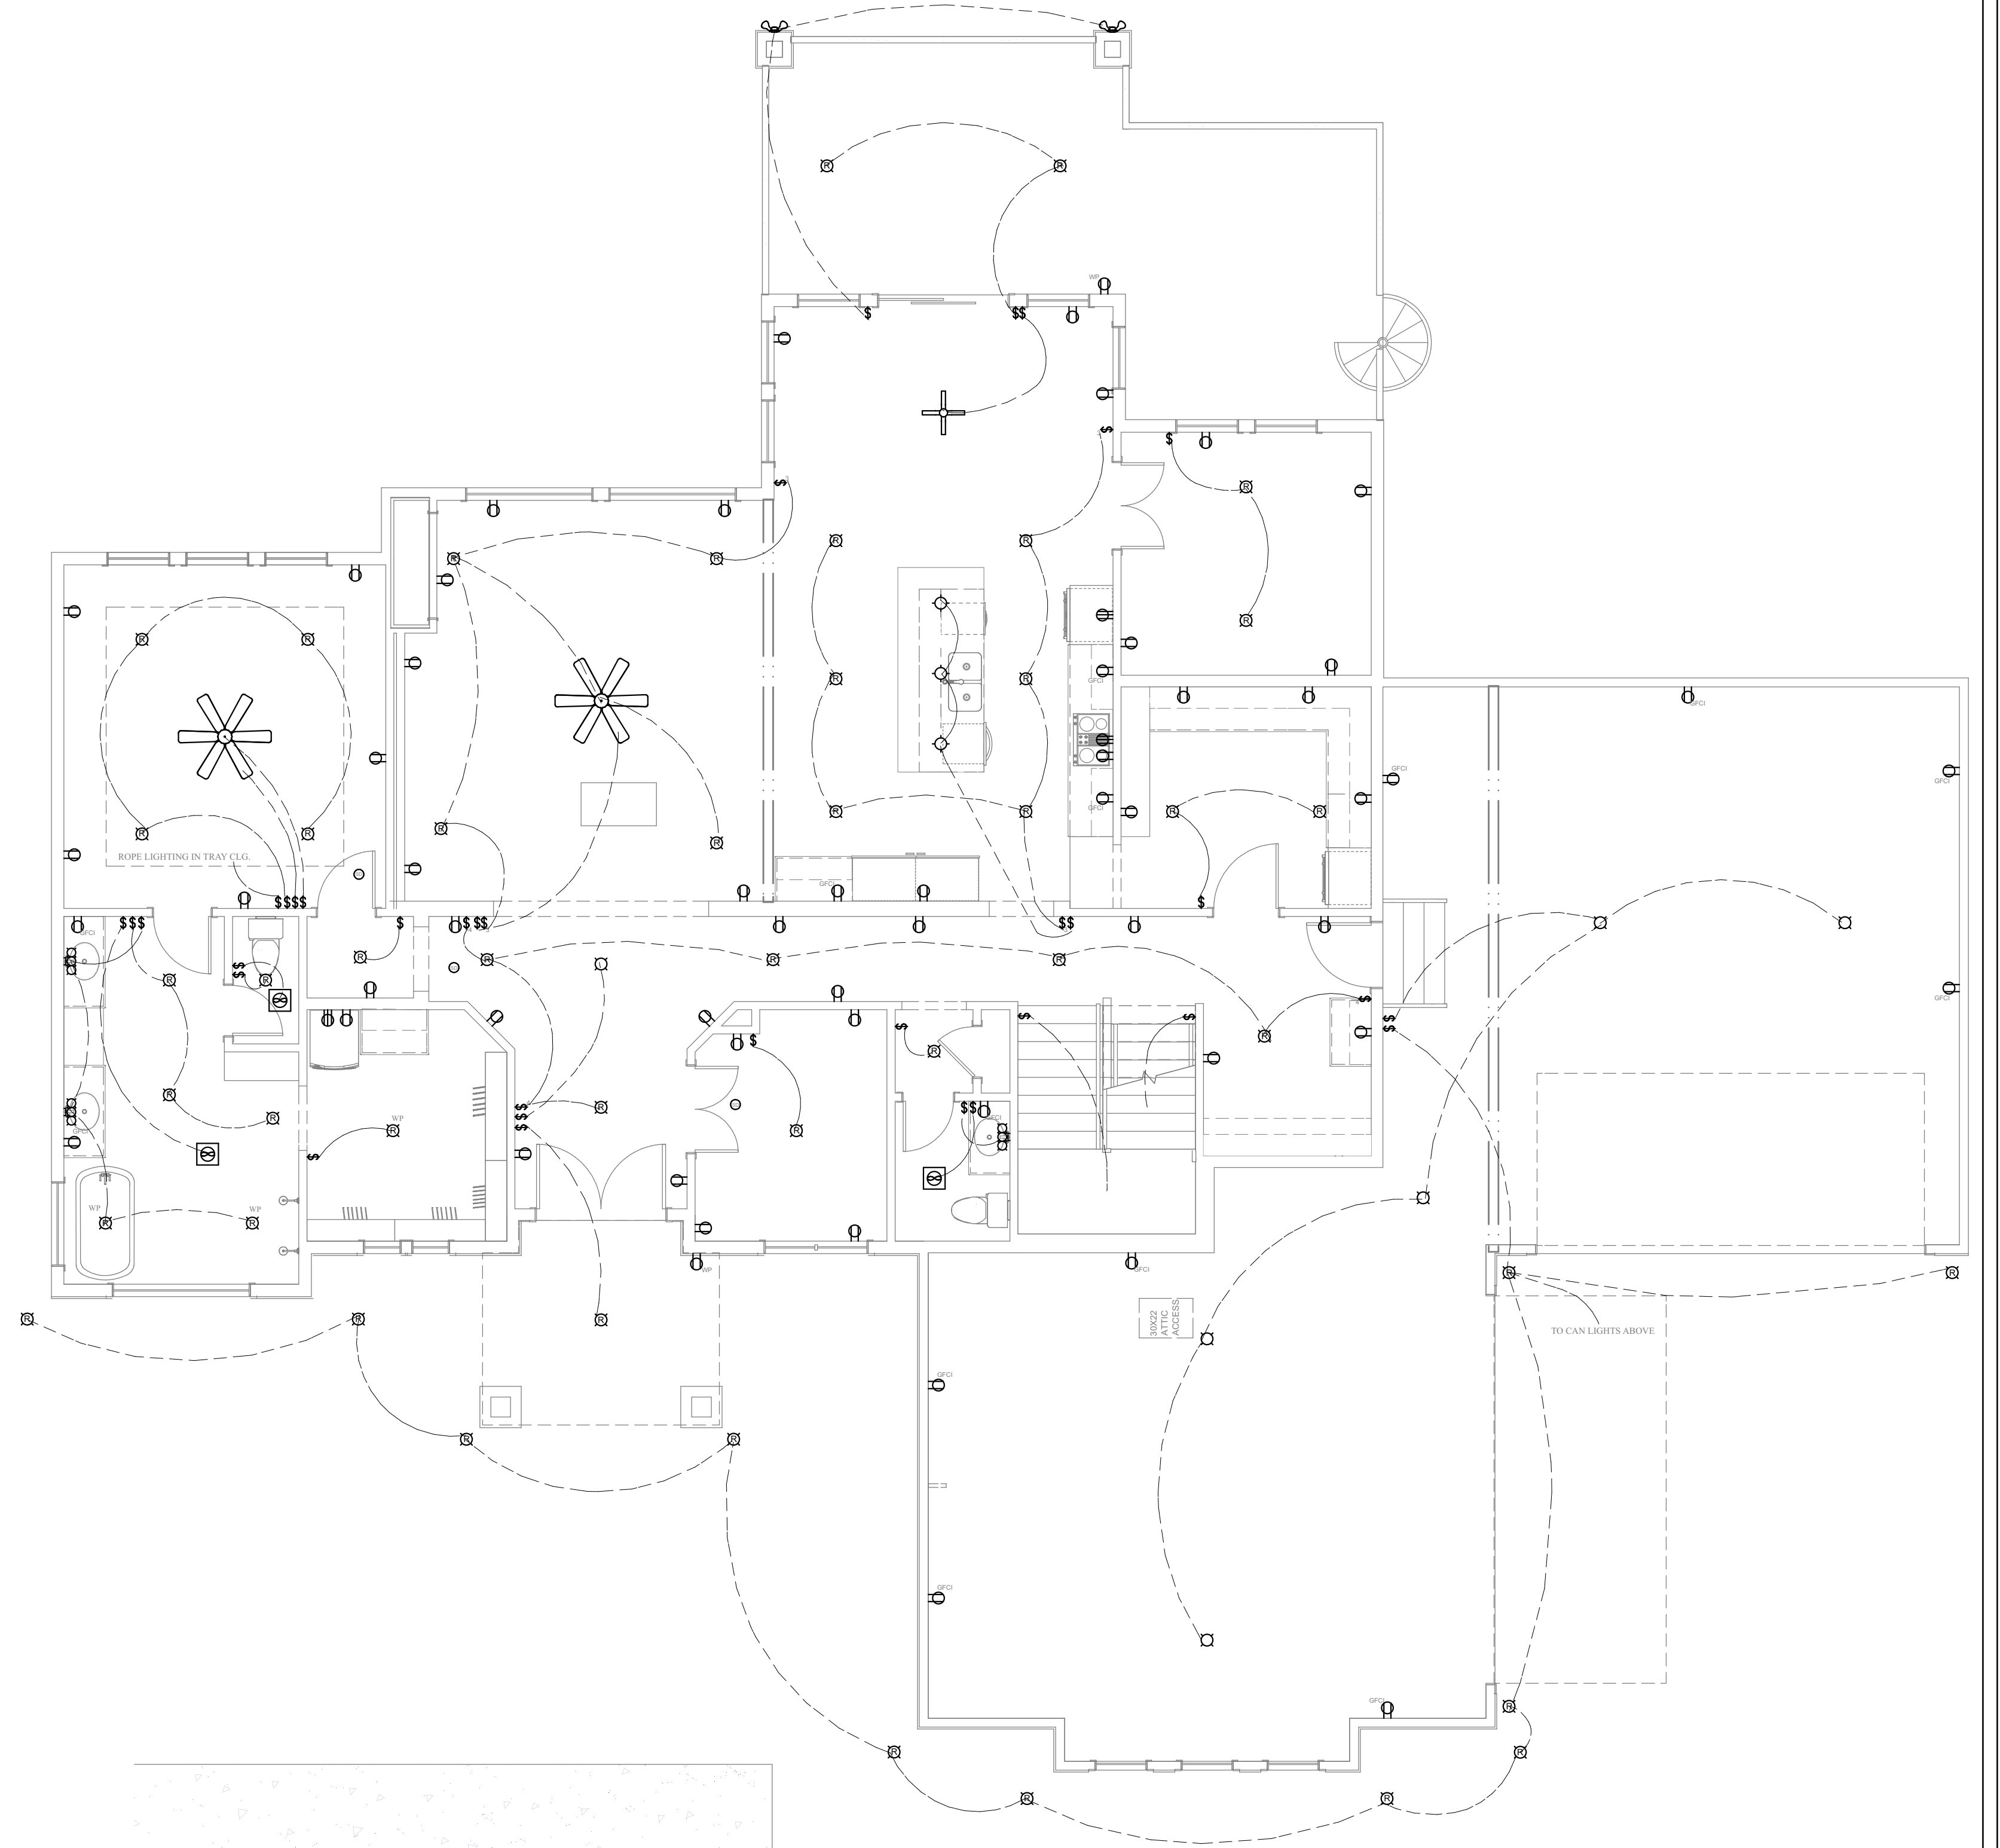

**MAIN FLOOR ELECTRICAL PLAN**

SCALE: 3/16" = 1'-0"

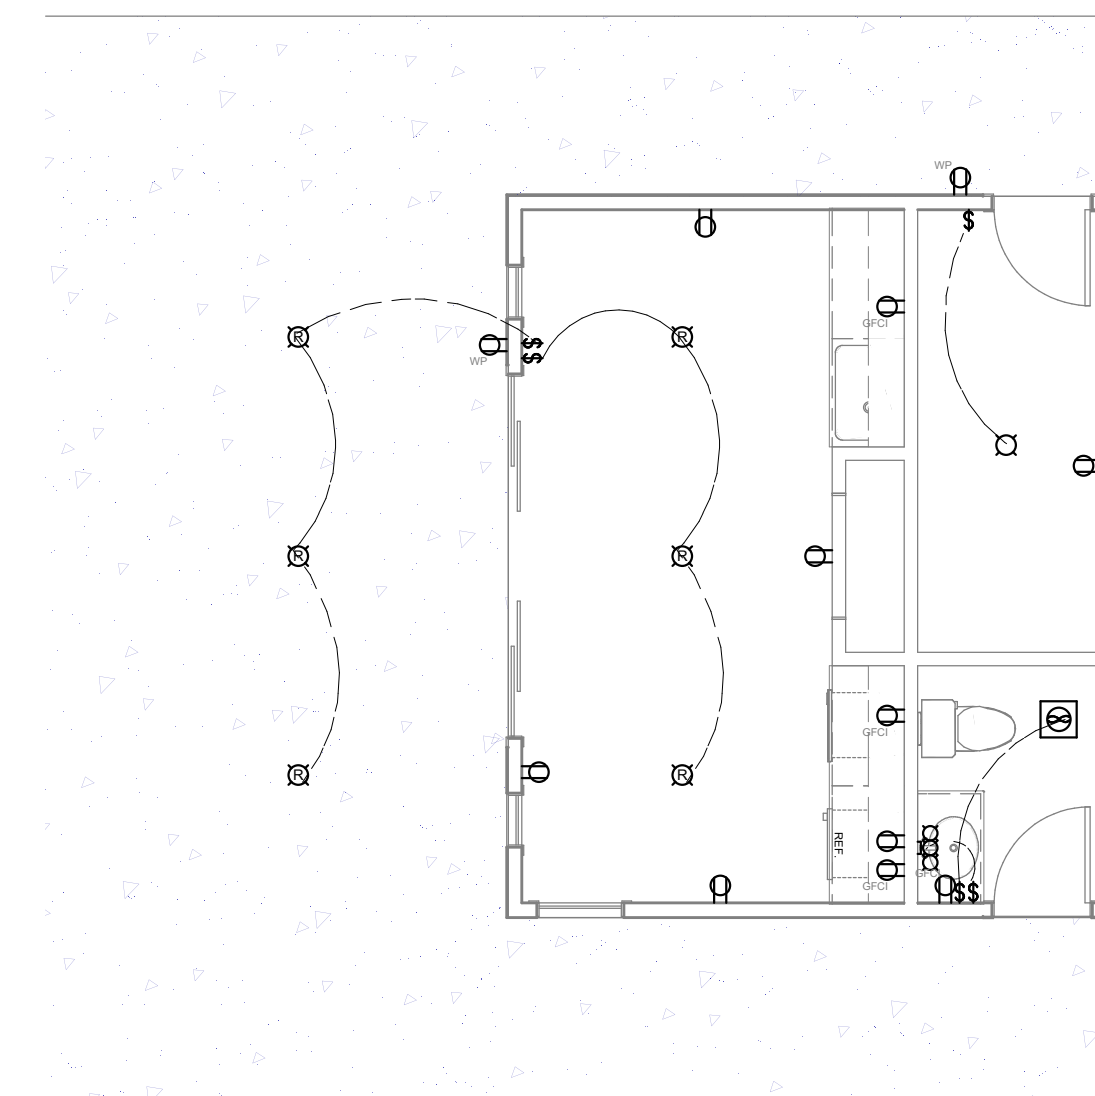

**POOL HOUSE ELECTRICAL PLAN**

SCALE: 3/16" = 1'-0"

NUMBER	DATE	REVISION TABLE	REVISOR	DESCRIPTION

THIS DRAWING IS THE PROPERTY OF VIRTUACTIVE, LLC. It is to be used for the exclusive use of the project for which it was prepared. No part of this drawing may be reproduced, stored in a retrieval system, or transmitted in any form or by any means, electronic, mechanical, photocopying, recording, or by any information storage and retrieval system, without the prior written permission of Virtuactive, LLC. Use of these drawings and concepts contained herein without the written permission of Virtuactive, LLC is prohibited. The contractor, sub-contractors, suppliers, and/or homeowners shall verify all dimensions, quantities, and materials shown on these drawings. The contractor shall check all drawings, specifications, and materials prior to construction and shall verify all dimensions, quantities, and materials shown on these drawings. Virtuactive, LLC and its representatives shall not be held liable for negligence on the job site due to lack of knowledge or lack of plan detail from the sub-contractors, suppliers, and/or homeowners. All dimensions shall be verified by the contractor, sub-contractors, suppliers, and/or homeowners.

PROJECT LOCATION:

PREPARED FOR:

**VIRTUACTIVE**  
**VirtuActive - 3D Drafting & Design**  
 331 Village Pointe Plaza, Suite 303, Omaha, NE 68118  
 www.VirtuActive.com | 402.379.8100  
 Designed by: Tony Elia | tony@virtuactive.com

DATE:

SHEET:

10 OF 10